


DAUGHPIN COUNTY, PENNSYLVANIA - LOWER SATARA TOWNSHIP
S3-0030-16

PROFILE VIEW

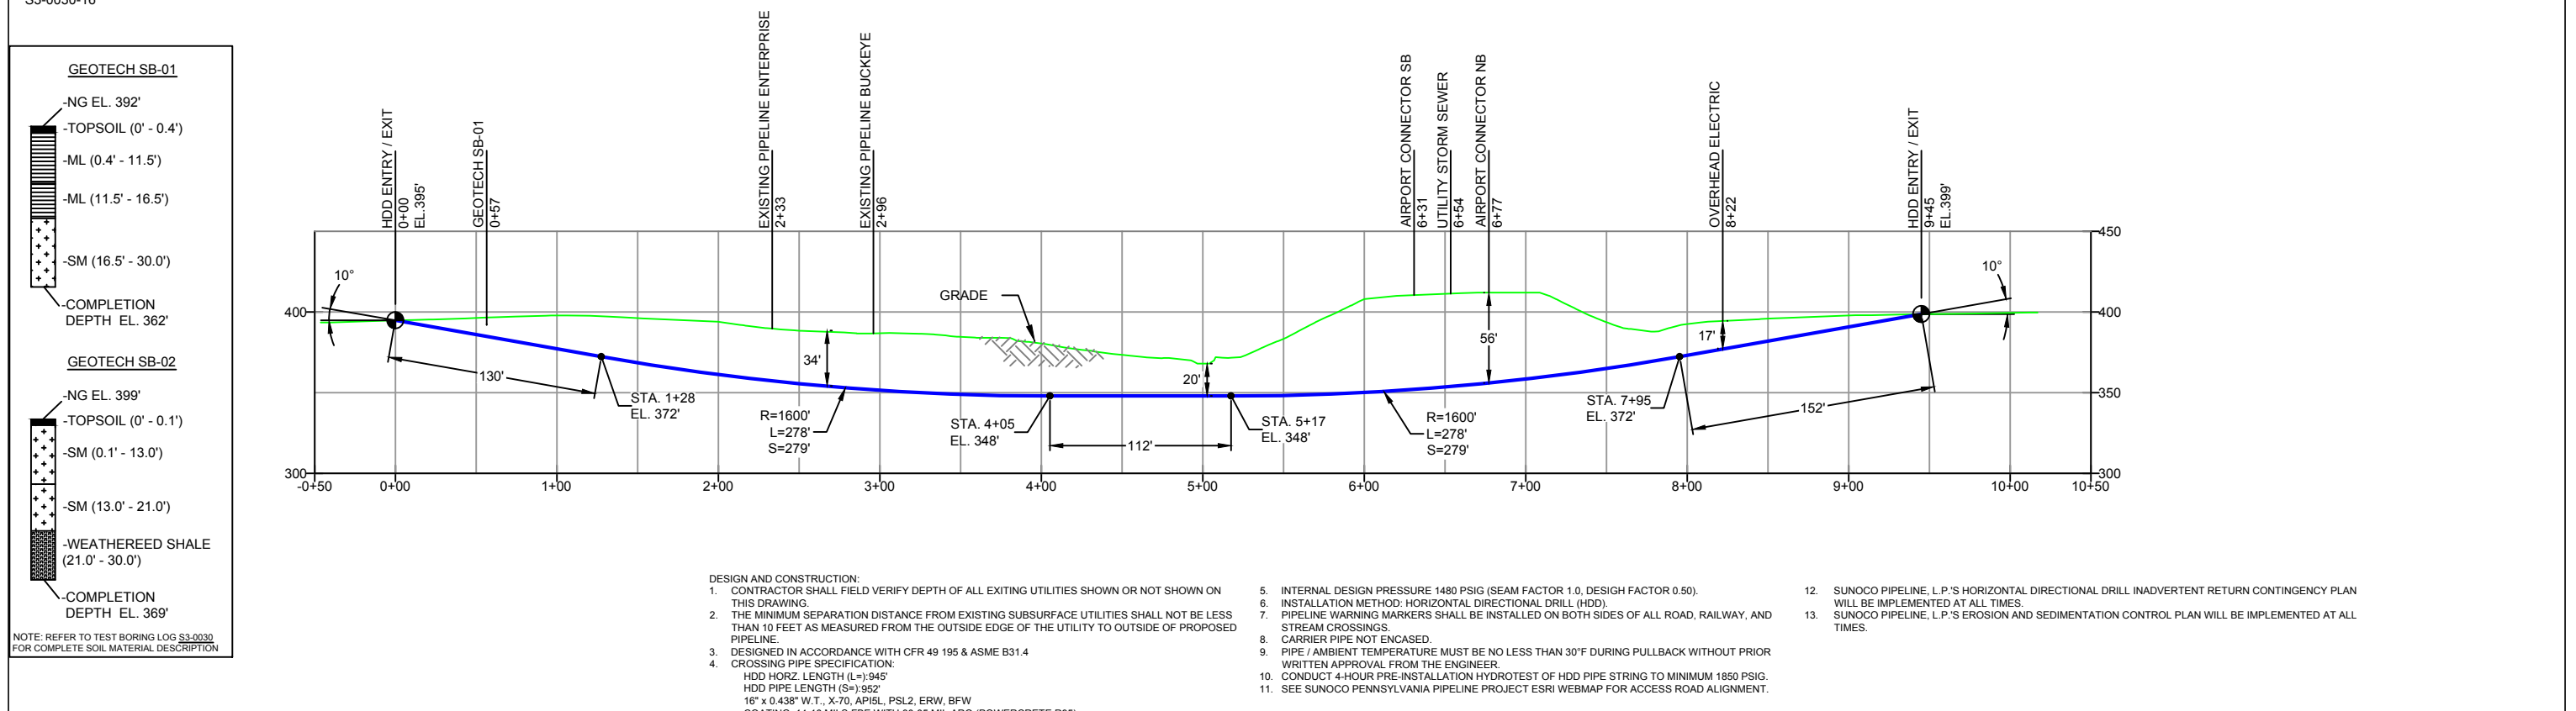

NOTES		REF. DRAWING		REVISIONS		SUNOCO PIPELINE, L.P.	
1. ALL COORDINATES SHOWN ARE IN LATITUDE AND LONGITUDE. ALL MSL ELEVATIONS ARE NAD83 2. STATIONING IS BASED ON HORIZONTAL DISTANCES 3. ROONEY ENGINEERING, INC. AND SUNOCO PIPELINE, LP ARE NOT RESPONSIBLE FOR LOCATION OF FOREIGN UTILITIES SHOWN IN PLOT PLAN OR PROFILE. THE INFORMATION SHOWN HEREON IS FURNISHED WITHOUT LIABILITY ON THE PART OF ROONEY ENGINEERING, INC. AND SUNOCO PIPELINE, LP. FOR ANY DAMAGES RESULTING FROM ERRORS OR OMISSIONS THEREIN. 4. CONTRACTOR IS RESPONSIBLE FOR LOCATING ALL UTILITIES. CONTACT ONE CALL AT 811 PRIOR TO DIGGING. 5. SUNOCO EMERGENCY HOTLINE NUMBER IS #1-800-786-7440.		ES-4.10	TO ES-4.10	EROSION & SEDIMENT PLAN			
		SHEET 6	TO SHEET 7	AERIAL SITE PLAN			
				EP2	REVISED PER PADEP COMMENTS RECEIVED 09-06-16	MRS	10/07/16
				EP1	REVISED PER PADEP COMMENTS	DLM	05/07/16
				EP		MRS	11/23/15
				A	ISSUED FOR BID	MRS	08/31/15
		DWG NO	DWG NO	DESCRIPTION	DESCRIPTION	BY	DATE
						CHK	DATE
						APP	DATE

Sunoco Logistics Partners L.P.

TETRA TECH ROONEY
(303) 792-5911

SUNOCO PIPELINE, L.P.

16-INCH HORIZONTAL DIRECTIONAL DRILL
HIGHWAY 3032
PENNSYLVANIA PIPELINE PROJECT

SCALE: 1"=100' DWG. NO. PA-DA-0020.0000-RD-16