


DELAWARE COUNTY PENNSYLVANIA, UPPER CHICHESTER TOWNSHIP
S3-0670-16

PROFILE VIEW

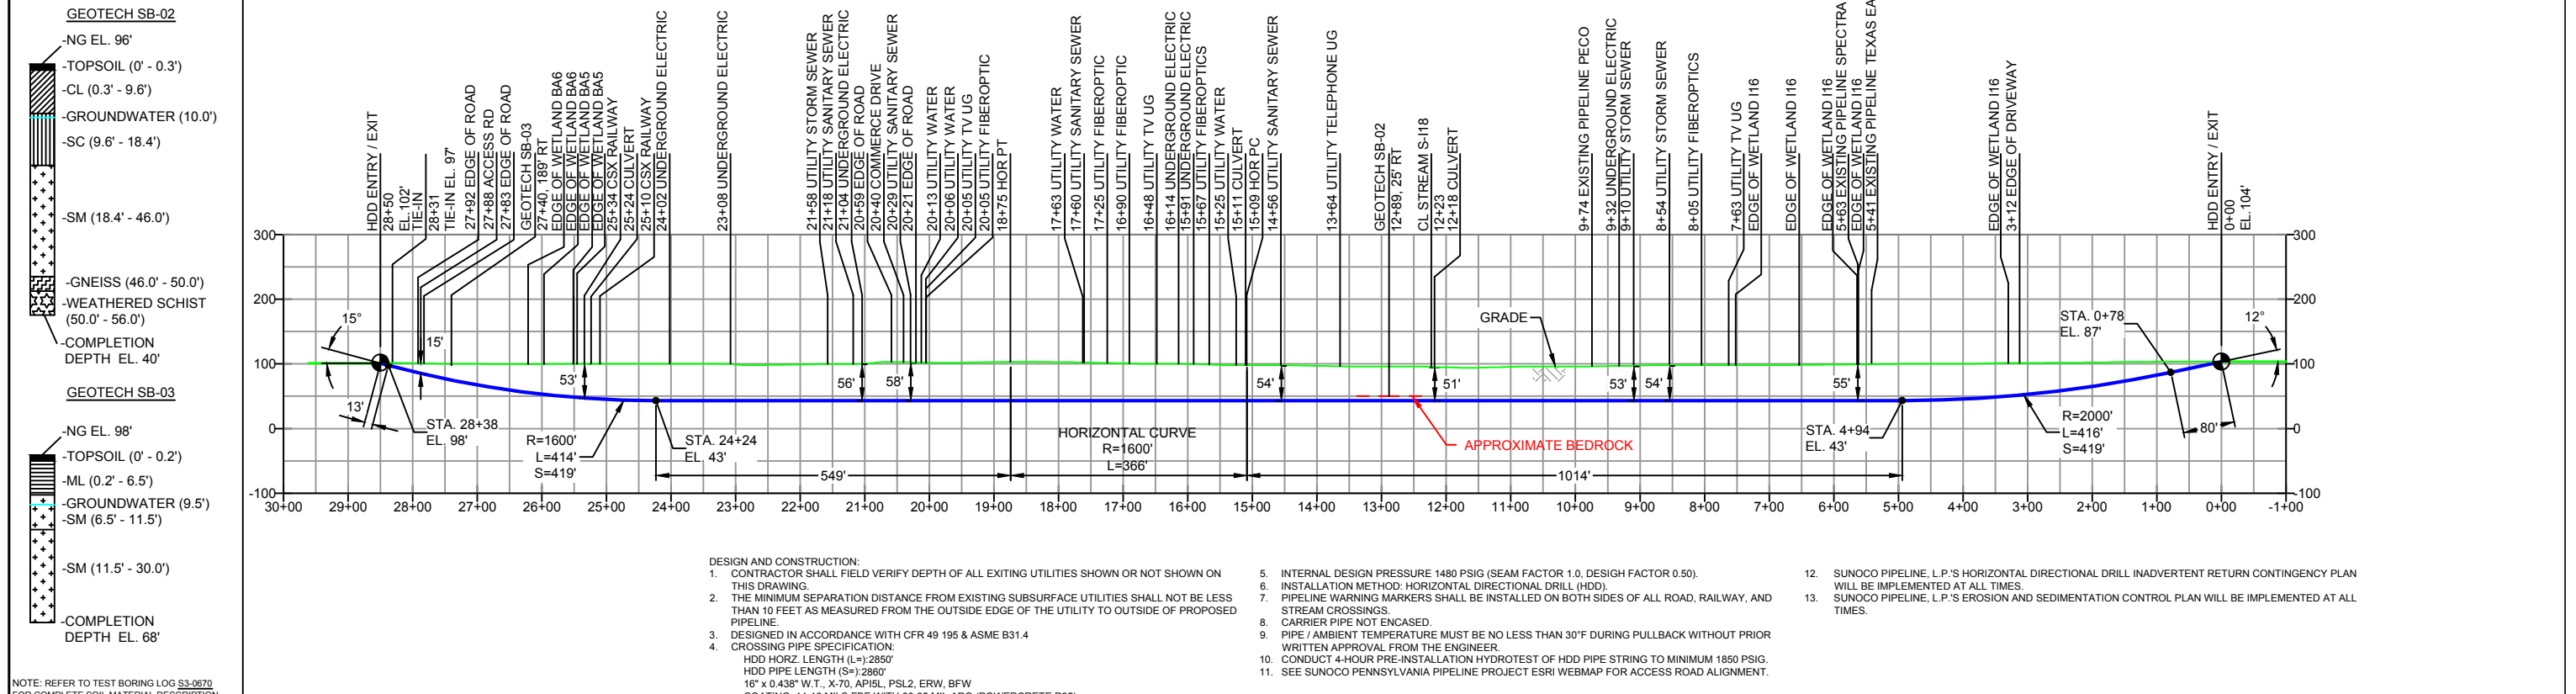

NOTES				REF. DRAWING		REVISIONS						Sunoco Logistics Partners L.P.		SUNOCO PIPELINE, L.P.			
1. ALL COORDINATES SHOWN ARE IN LATITUDE AND LONGITUDE. ALL MSL ELEVATIONS ARE NAD83 2. STATIONING IS BASED ON HORIZONTAL DISTANCES 3. ROONEY ENGINEERING, INC. AND SUNOCO PIPELINE, LP ARE NOT RESPONSIBLE FOR LOCATION OF FOREIGN UTILITIES SHOWN IN PLOT PLAN OR PROFILE. THE INFORMATION SHOWN HEREON IS FURNISHED WITHOUT LIABILITY ON THE PART OF ROONEY ENGINEERING, INC. AND SUNOCO PIPELINE, LP. FOR ANY DAMAGES RESULTING FROM ERRORS OR OMISSIONS THEREIN. 4. CONTRACTOR IS RESPONSIBLE FOR LOCATING ALL UTILITIES. CONTACT ONE CALL AT 811 PRIOR TO DIGGING. 5. SUNOCO EMERGENCY HOTLINE NUMBER IS #1-800-786-7440.				ES-6.32	TO	ES-6.34	EROSION & SEDIMENT PLAN	EP2	REVISED PER PADEP COMMENTS RECEIVED 09-06-16	DLM	10/07/16	RMB	10/07/16	AAW	10/07/16	16-INCH HORIZONTAL DIRECTIONAL DRILL COMMERCE DRIVE / CSX RAILROAD PENNSYLVANIA PIPELINE PROJECT	
				SHEET 21	TO	SHEET 22	AERIAL SITE PLAN	EP1	REVISED PER PADEP COMMENTS	MRS	05/10/16	RMB	05/10/16	AAW	05/10/16		
								EP		MRS	12/08/15	RMB	12/08/15	AAW	12/08/15	SCALE: 1"=250' DWG. NO. PA-DE-0104.0023-RR-16	
								B	ISSUED FOR BID	MRS	08/31/15	RMB	08/31/15	AAW	08/31/15		
								A	ISSUED FOR REVIEW	MRS	08/14/15	RMB	08/14/15	AAW	08/14/15		
				DWG NO		DWG NO	DESCRIPTION	NO.	DESCRIPTION	BY	DATE	CHK	DATE	APP	DATE		

