


DELAWARE COUNTY PENNSYLVANIA, UPPER CHICHESTER TOWNSHIP  
S3-0670

**PROFILE VIEW**

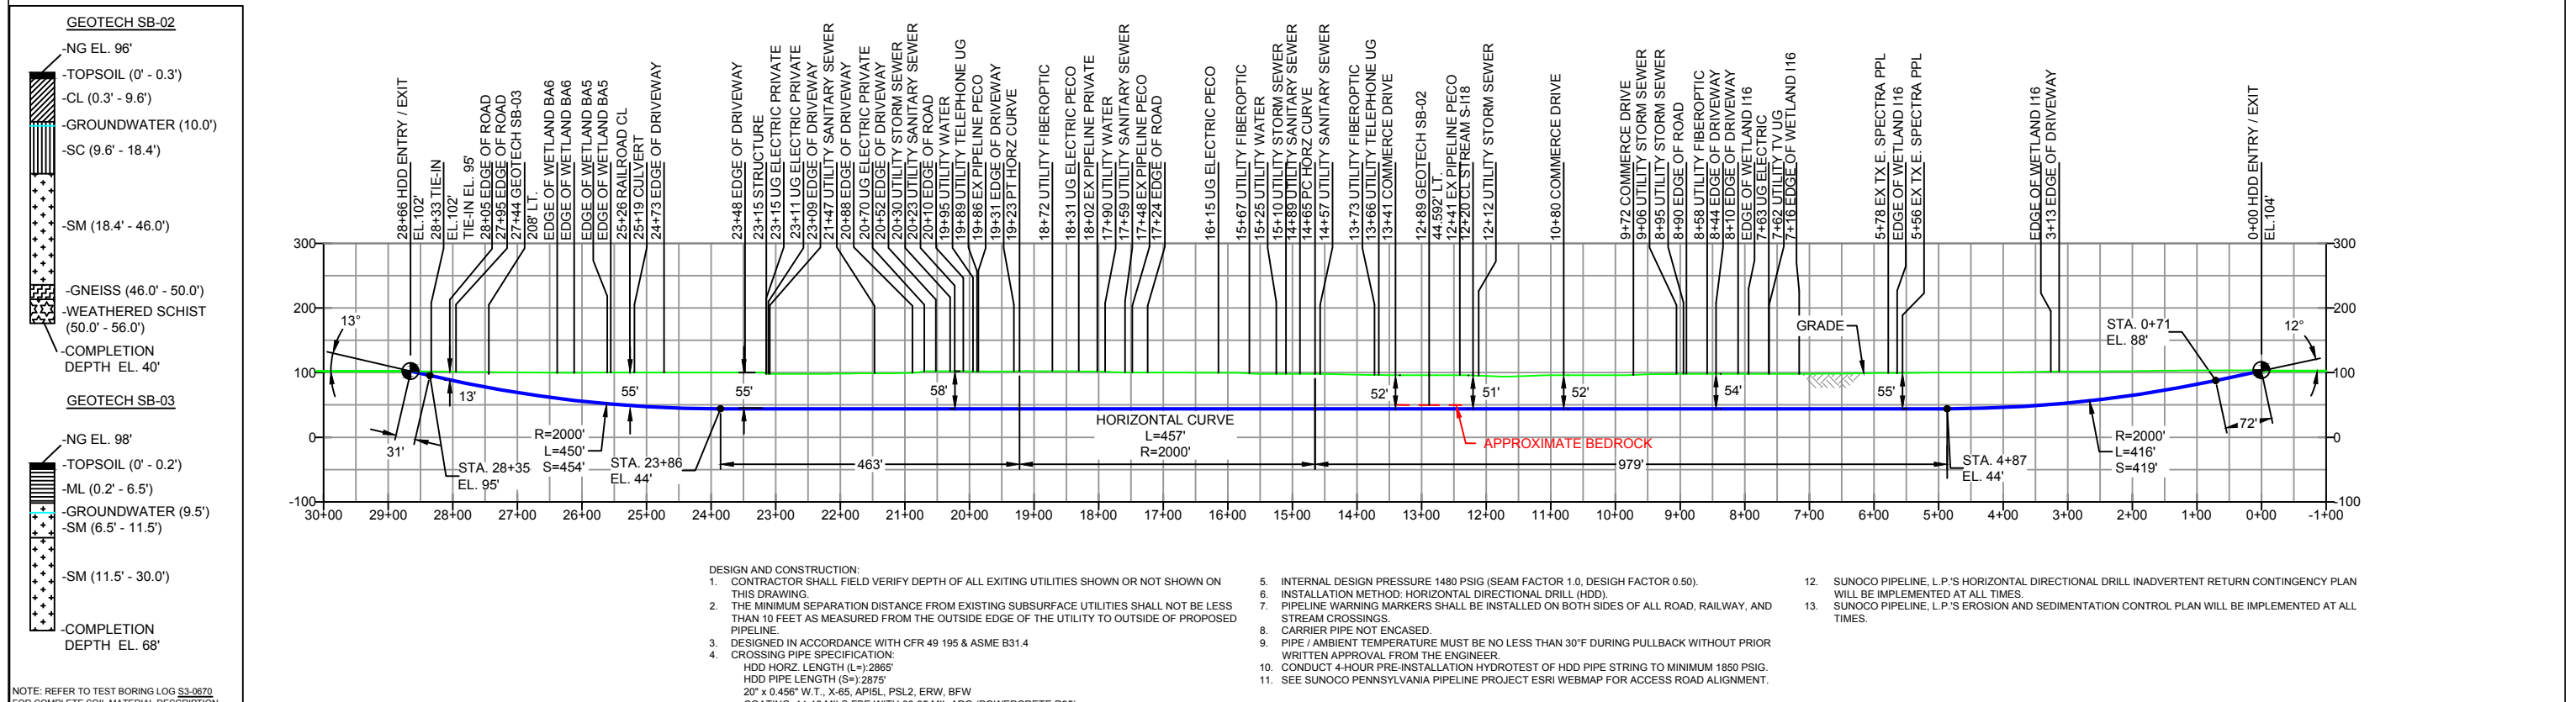

**NOTES**

- ALL COORDINATES SHOWN ARE IN LATITUDE AND LONGITUDE. ALL MSL ELEVATIONS ARE NAD83
- STATIONING IS BASED ON HORIZONTAL DISTANCES
- ROONEY ENGINEERING, INC. AND SUNOCO PIPELINE, LP ARE NOT RESPONSIBLE FOR LOCATION OF FOREIGN UTILITIES SHOWN IN PLOT PLAN OR PROFILE. THE INFORMATION SHOWN HEREON IS FURNISHED WITHOUT LIABILITY ON THE PART OF ROONEY ENGINEERING, INC. AND SUNOCO PIPELINE, LP. FOR ANY DAMAGES RESULTING FROM ERRORS OR OMISSIONS THEREIN.
- CONTRACTOR IS RESPONSIBLE FOR LOCATING ALL UTILITIES. CONTACT ONE CALL AT 811 PRIOR TO DIGGING.
- SUNOCO EMERGENCY HOTLINE NUMBER IS #1-800-786-7440.

REF. DRAWING	DESCRIPTION	NO.	DESCRIPTION
ES-6.32 TO ES-6.34	EROSION & SEDIMENT PLAN	EP2	REVISED PER PADEP COMMENTS RECEIVED 09-06-16
SHEET 21 TO SHEET 22	AERIAL SITE PLAN	EP1	REVISED PER PADEP COMMENTS
		C	ISSUED FOR BID
		B	ISSUED FOR BID
		A	ISSUED FOR REVIEW

**Sunoco Logistics  
Partners L.P.**

**SUNOCO PIPELINE, L.P.**

20-INCH HORIZONTAL DIRECTIONAL DRILL  
COMMERCE DRIVE / CSX RAILROAD  
PENNSYLVANIA PIPELINE PROJECT

**TETRA TECH ROONEY**  
(303) 792-5911

SCALE: 1"=250'

DWG. NO. PA-DE-0104.0023-RR