


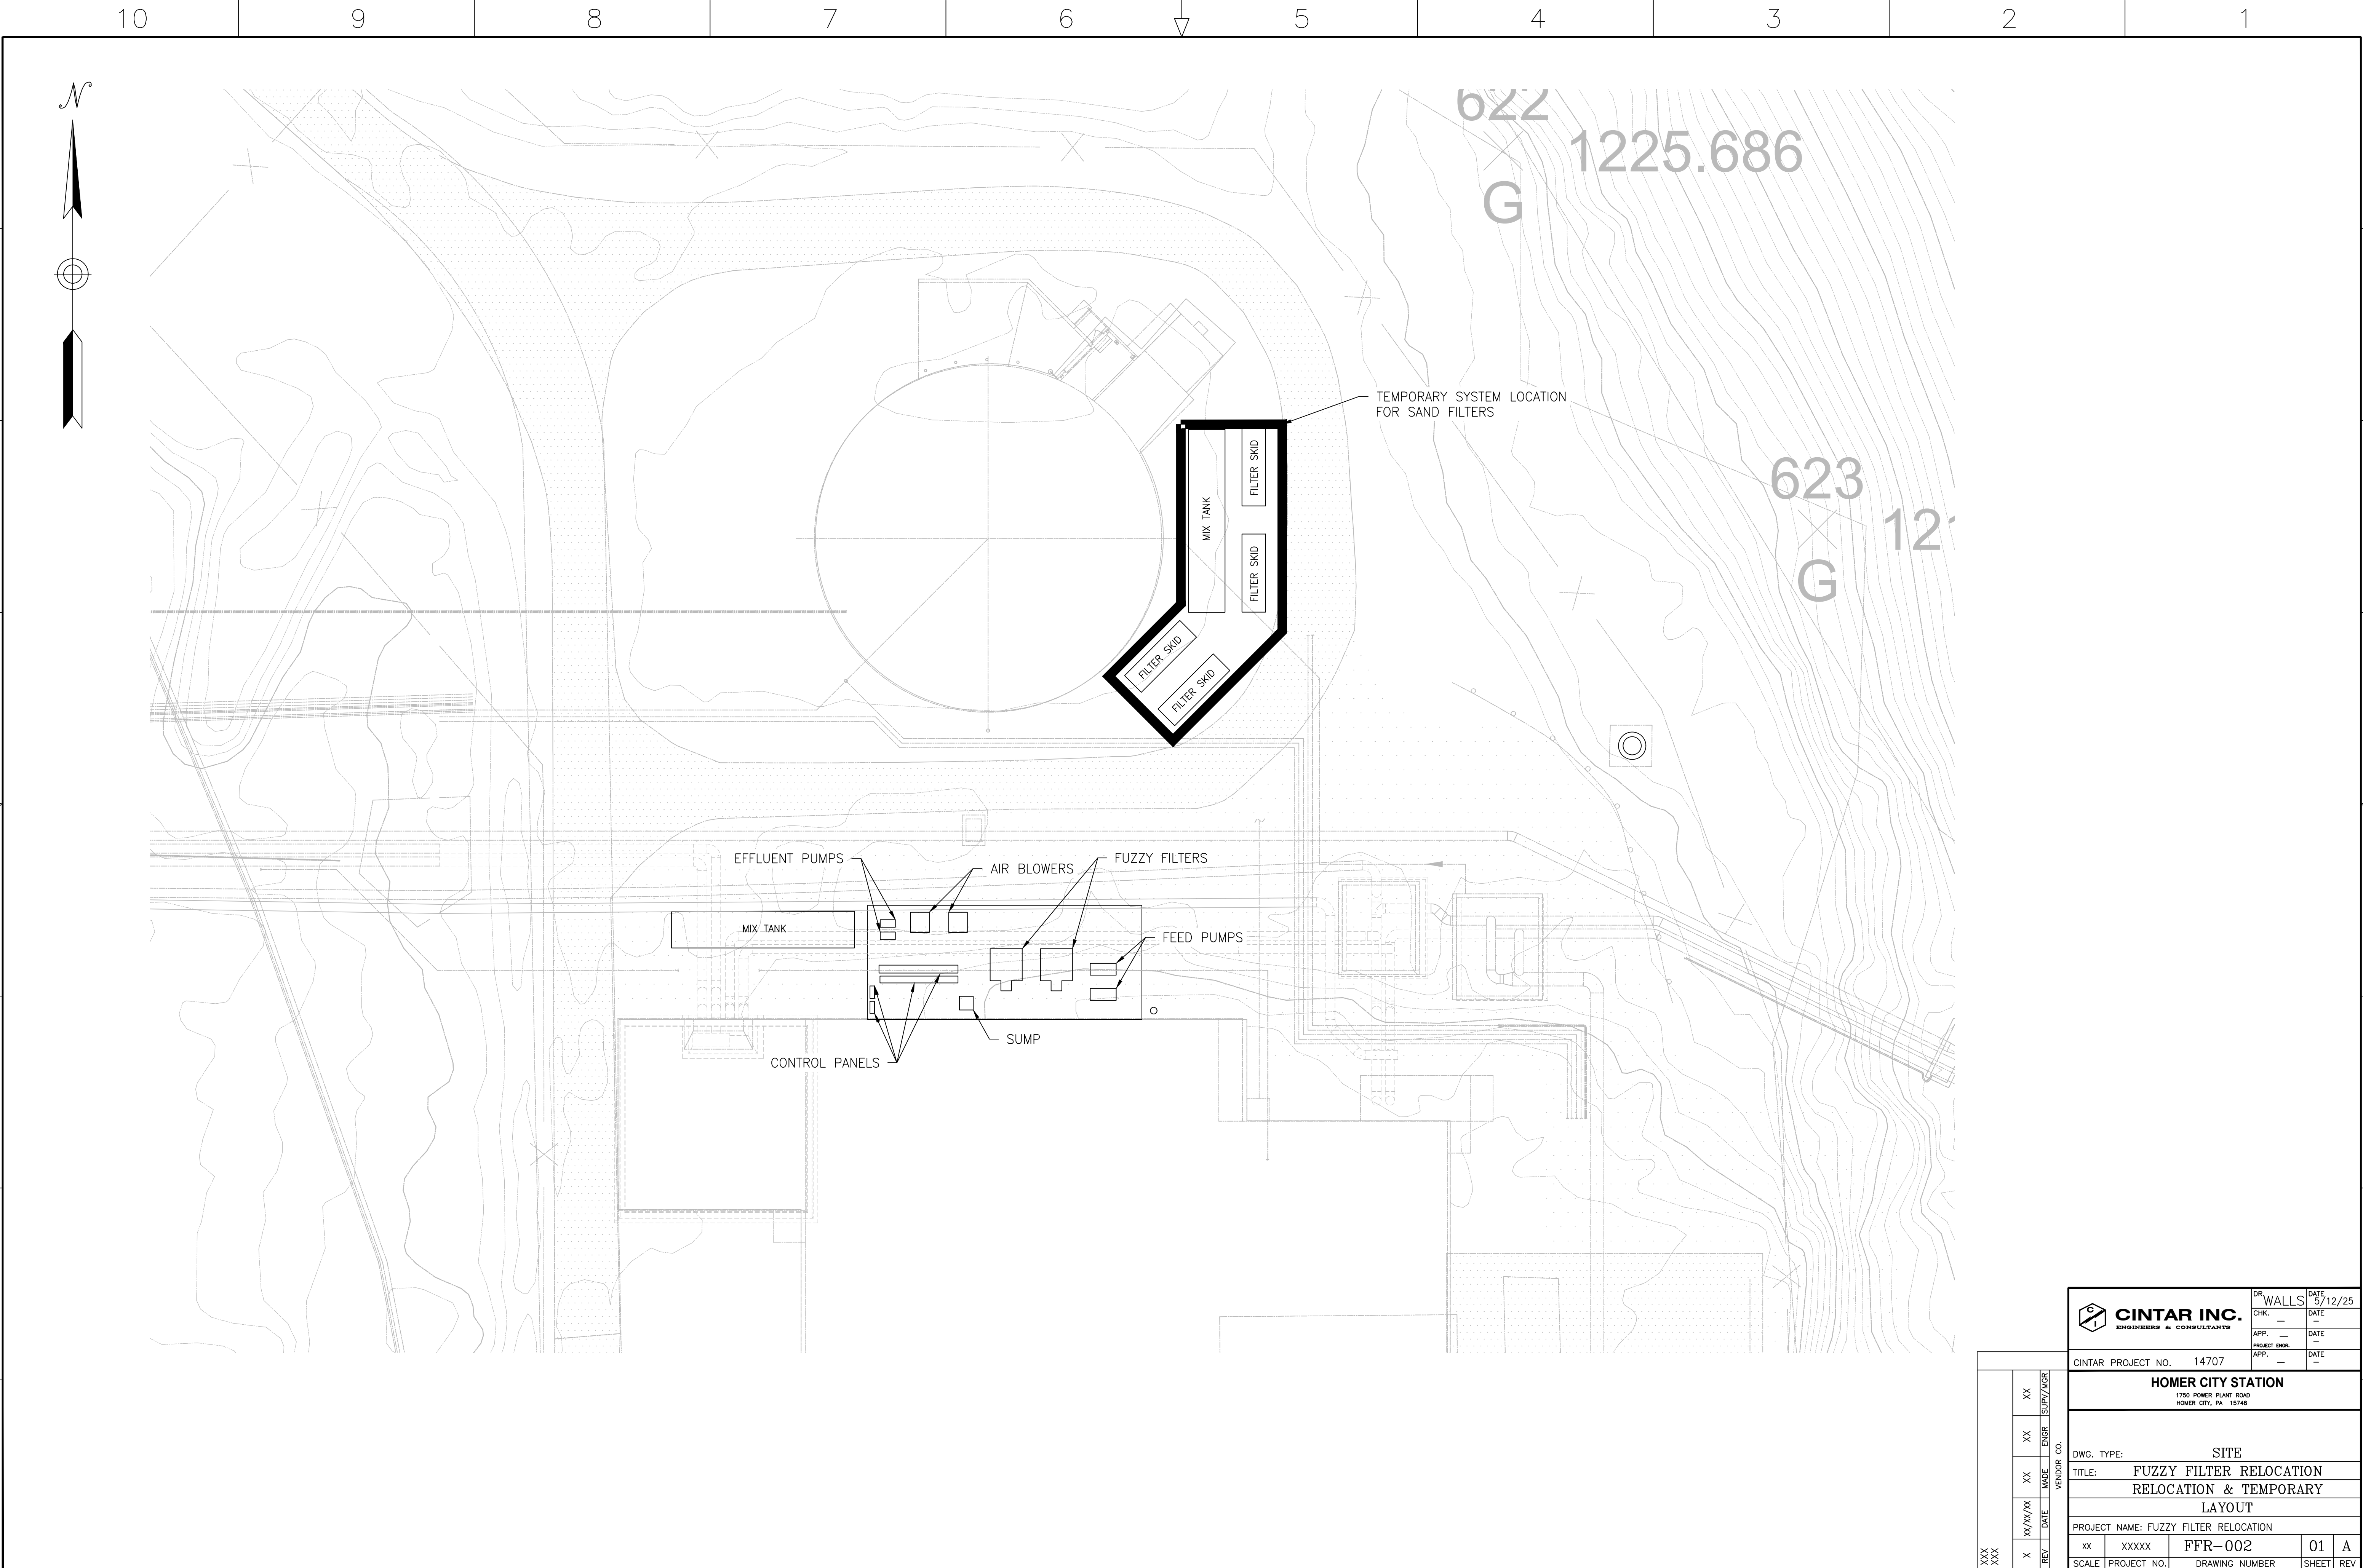

 CINTAR INC. ENGINEERS & CONSULTANTS		DR. WALLS		DATE	
		CHK.	—	DATE	—
		APP.	—	DATE	—
		PROJECT ENGR.	—	DATE	—
CINTAR PROJECT NO. 14707		5/12/25			
HOMER CITY STATION 1750 POWER PLANT ROAD HOMER CITY, PA 15746					
DWG. TYPE: SITE					
TITLE: FUZZY FILTER RELOCATION					
RELOCATION & TEMPORARY					
LAYOUT					
PROJECT NAME: FUZZY FILTER RELOCATION					
xx	xxxxx	FFR-002	01	A	
SCALE	PROJECT NO.	DRAWING NUMBER	SHEET	REV	
HOMER CITY CAD FILE: XXXXXXXX.DWG					

XXX XXX	REV	X	DATE	XX/XX/XX	MADE	ENGR	SUPERVISOR	XX
		XX	XX					
		XX	XX					
		XX	XX					