



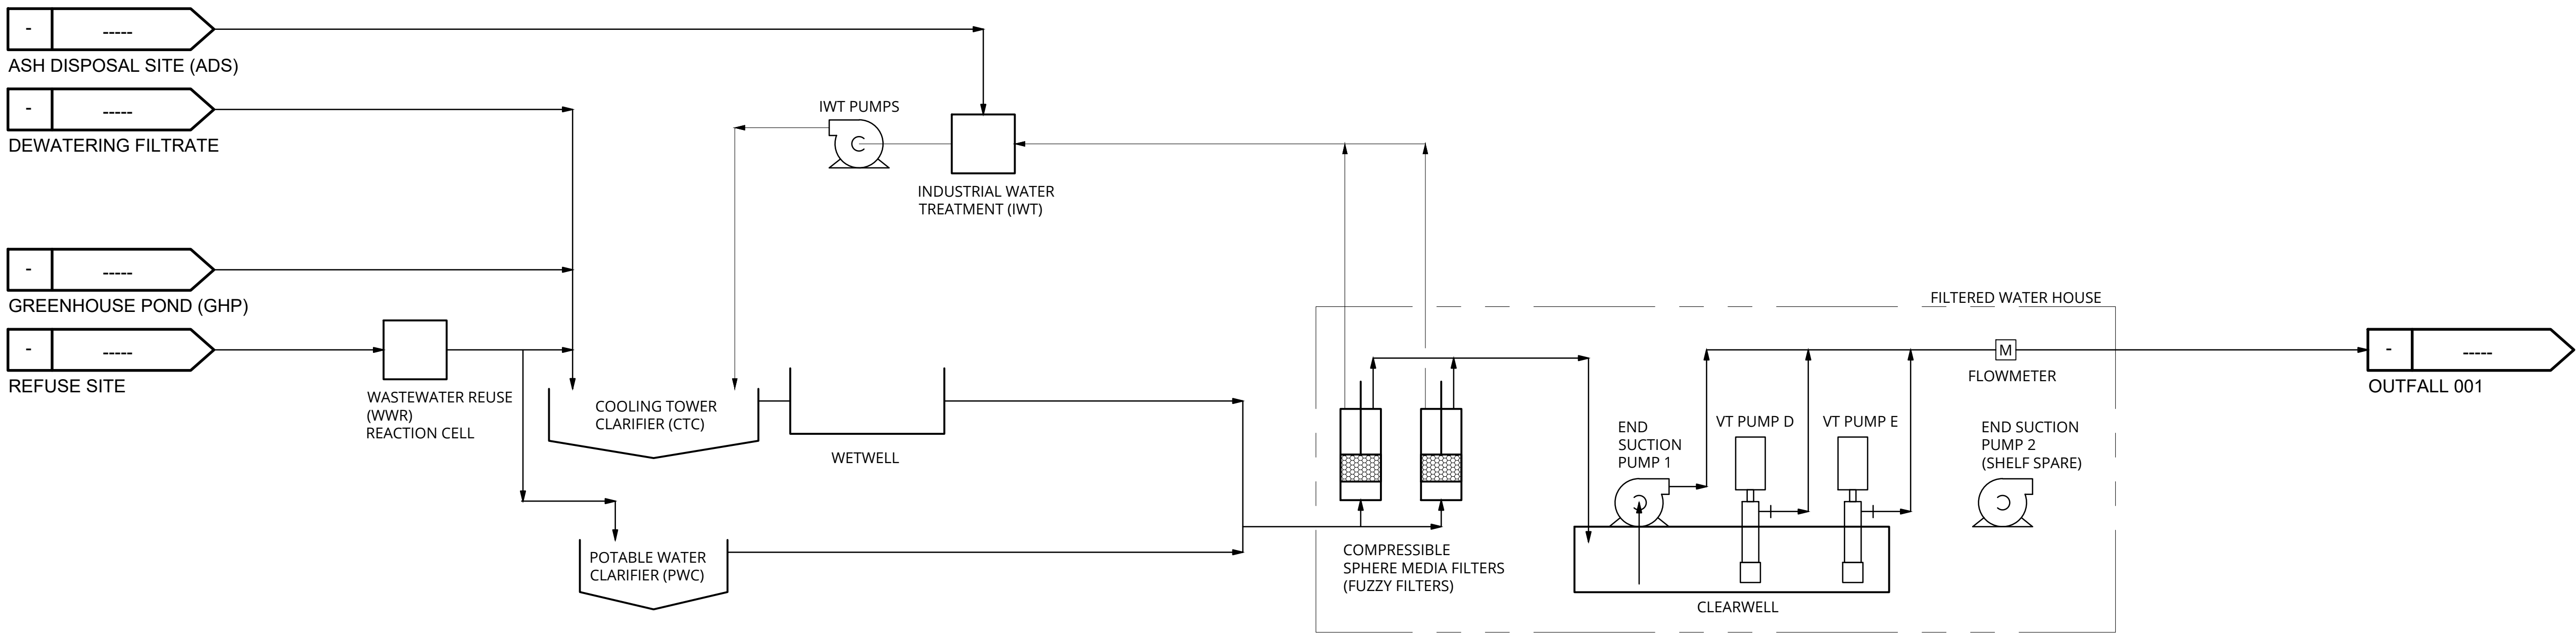

EXISTING SYSTEM WATER
FLOW DIAGRAM

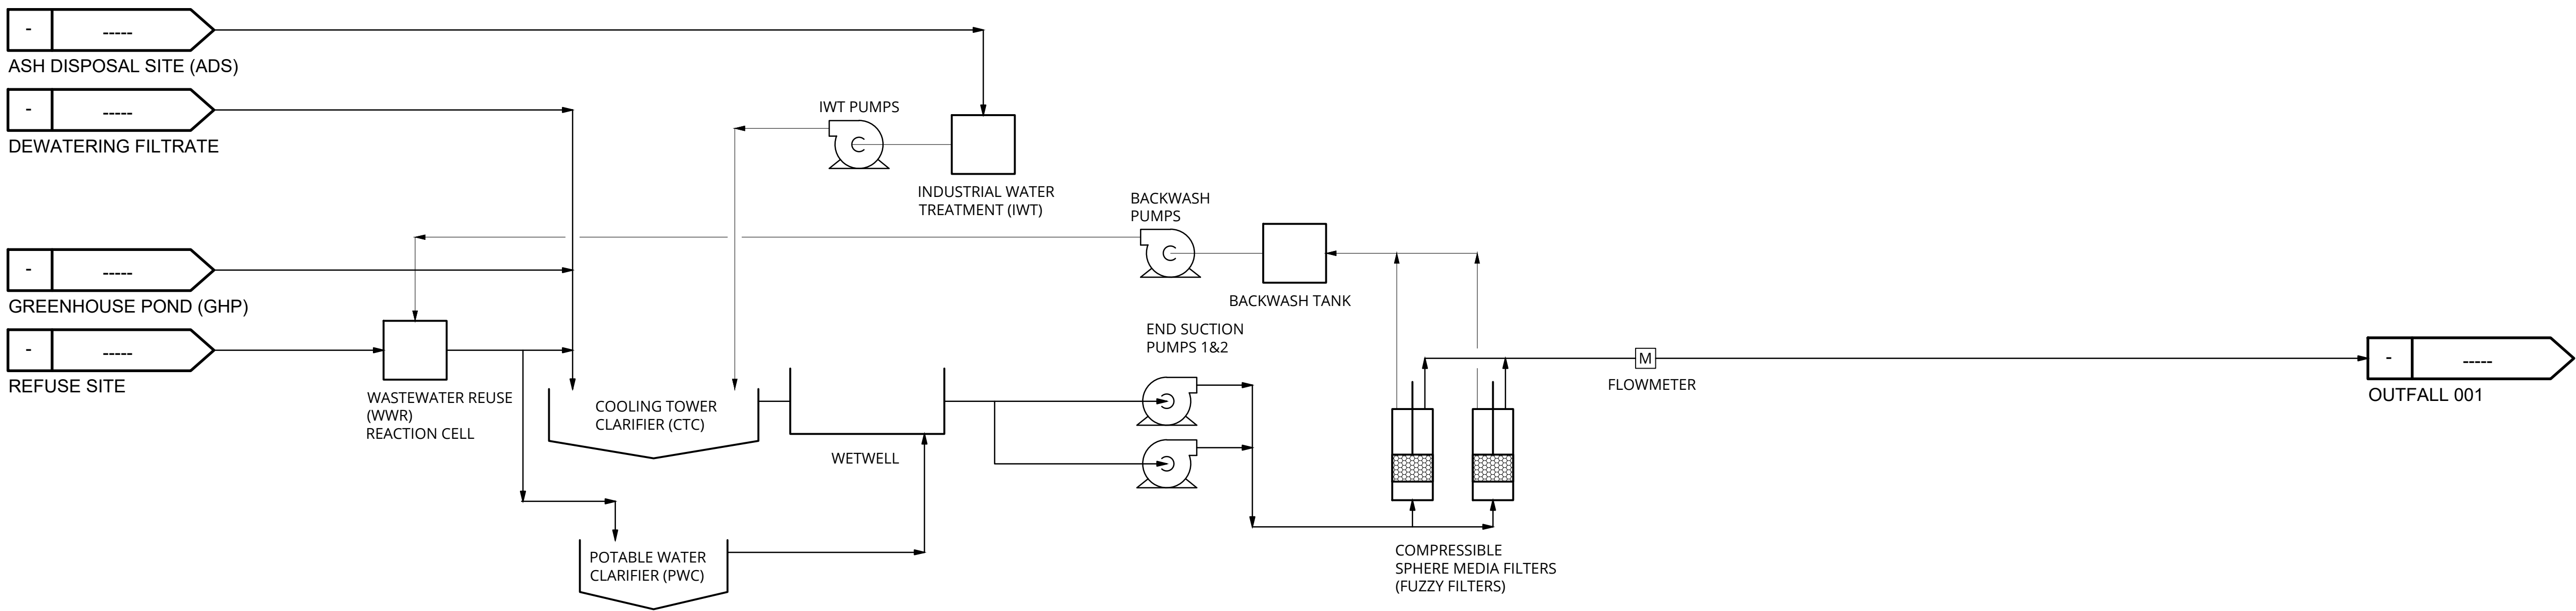

RELOCATED SYSTEM
WATER FLOW DIAGRAM

REV	DATE	DESCRIPTION
A	05/12/2025	SCHEMATIC DESIGN
B	05/15/2025	SCHEMATIC DESIGN REVISION

 HOMER CITY REDEVELOPMENT 1750 POWER PLANT ROAD HOMER CITY, PA 15748			
 V-SYSTEMS 101 FAIRVIEW AVENUE PITTSBURGH, PA 15238 412-826-9200 SALES@V-SYST.COM			
PROCESS			
OUTFALL 001 FILTER SYSTEM PROCESS FLOW DIAGRAM			
DESIGNED	J VANGHEUCHTEN	CHECKED	R HUFFMYER
2025-C001	HCR FILTER RELOCATION		
PROJECT NO.	PROJECT NAME		
NA	G-01		
SCALE	DRAWING NUMBER		