



PLAN
SCALE: 1"=20'

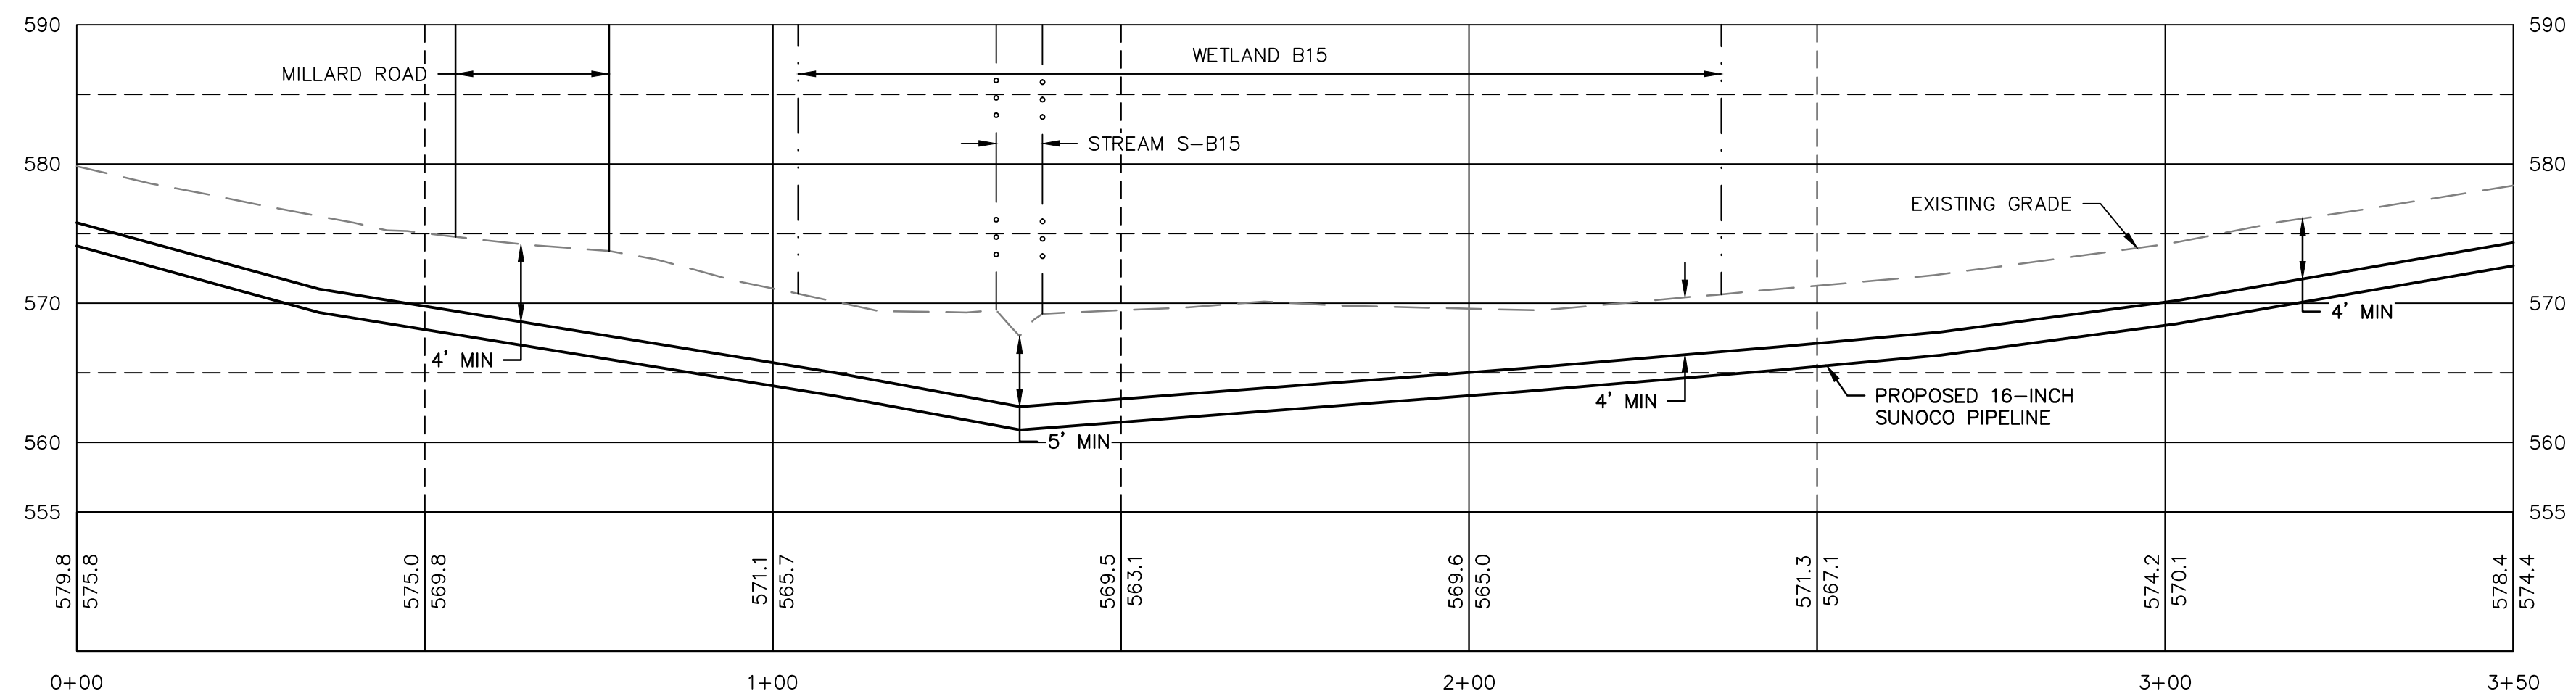

PLAN
HORZ SCALE: 1"=20'
VERT SCALE: 1"=10'

GRAPHIC SCALE

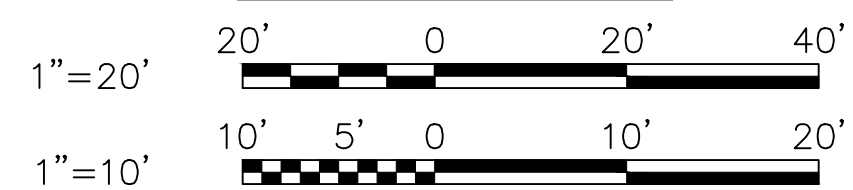

STV
Baltimore, MD Bismarck, ND Denver, CO Douglassville, PA Houston, TX
Pittsburgh, PA Williamsport, PA

THE LOCATION OF THE PIPELINE FACILITIES AS SHOWN HEREON MUST BE CONSIDERED AS APPROXIMATE ONLY. BEFORE DIGGING OR FOR AN EXACT LOCATION PLEASE CONTACT YOUR STATES UNDERGROUND UTILITY LOCATION SERVICE.

STV PROJECT No.: 38-17335

REV.	DATE	APP#	DESCRIPTION	APPROVAL
ENGINEERING RECORD				
			DRAWN BY: CNN	
			CHECKED BY: RJC	
			APPROVED BY: CDA	
			DATE: 03/17/16	
			SCALE: AS NOTED	
OLD DRAWING NO.			DWG. NO.	REV. NO.
			S-B15-B15-C-101	0

Sunoco Logistics Partners L.P.

PENNSYLVANIA PIPELINE PROJECT
STREAM S-B15 WETLAND B15
EROSION & SEDIMENTATION
CONTROL PLAN AND PROFILE

CHESTER COUNTY, PA